

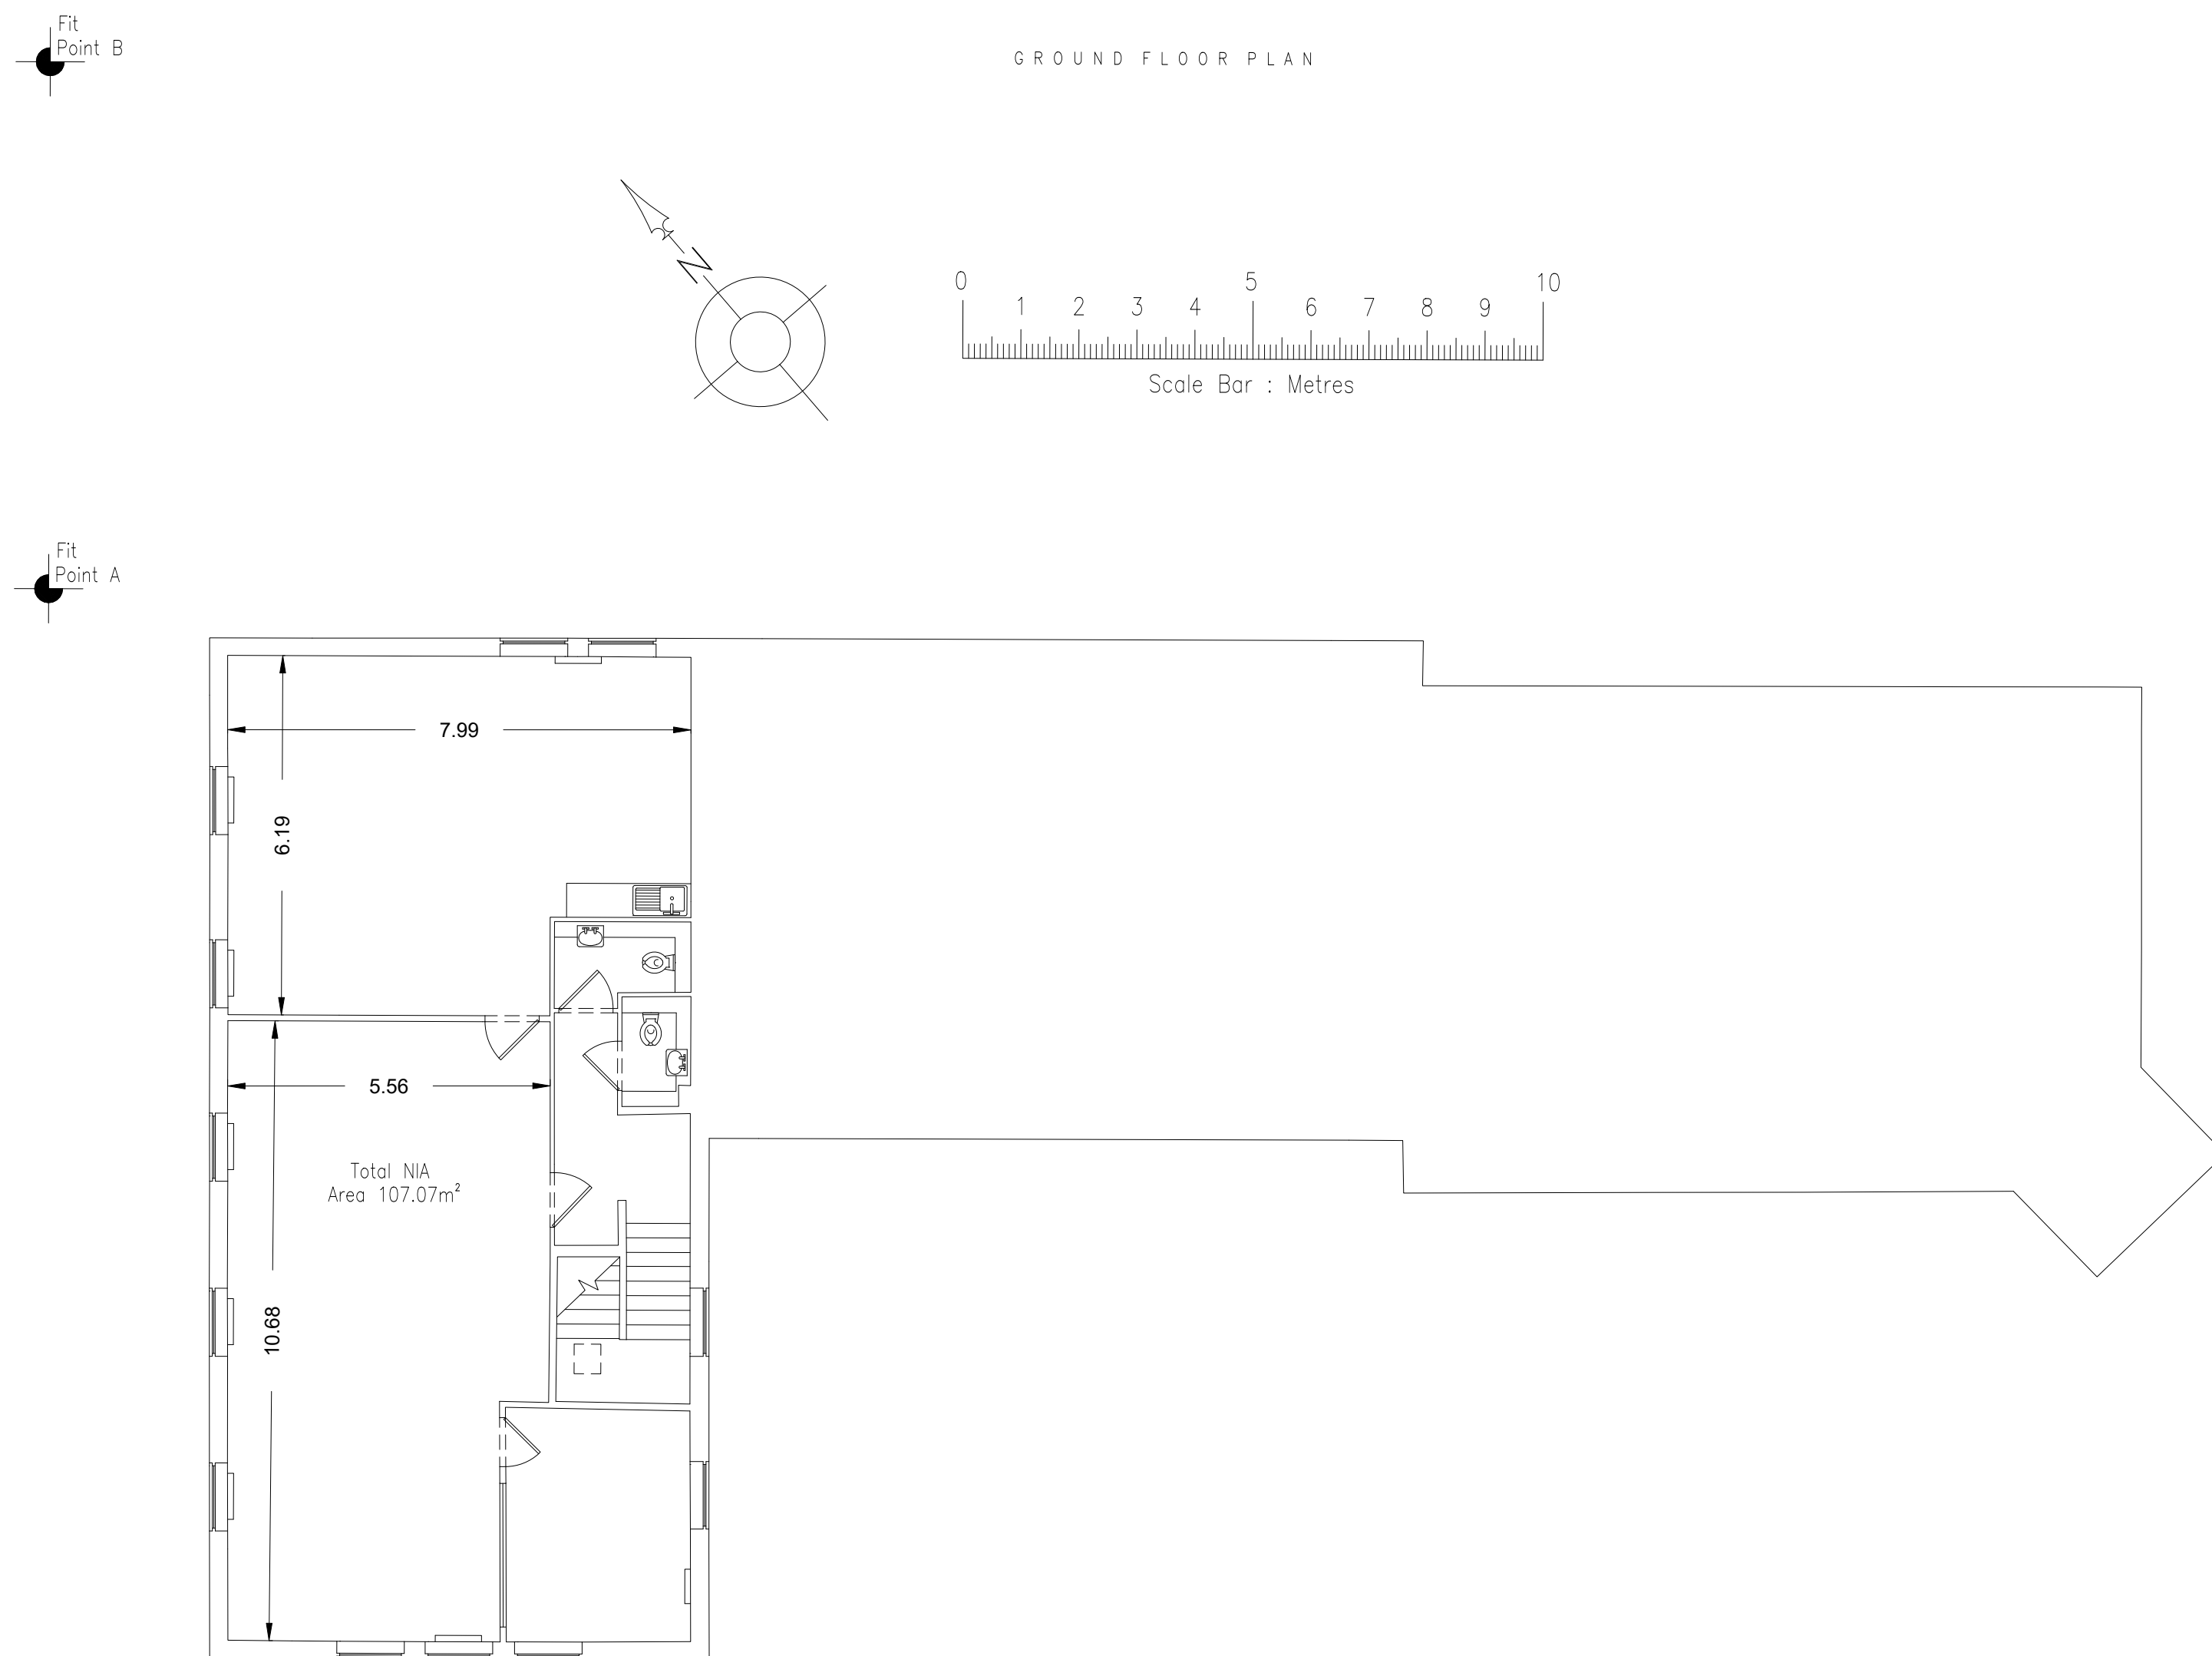


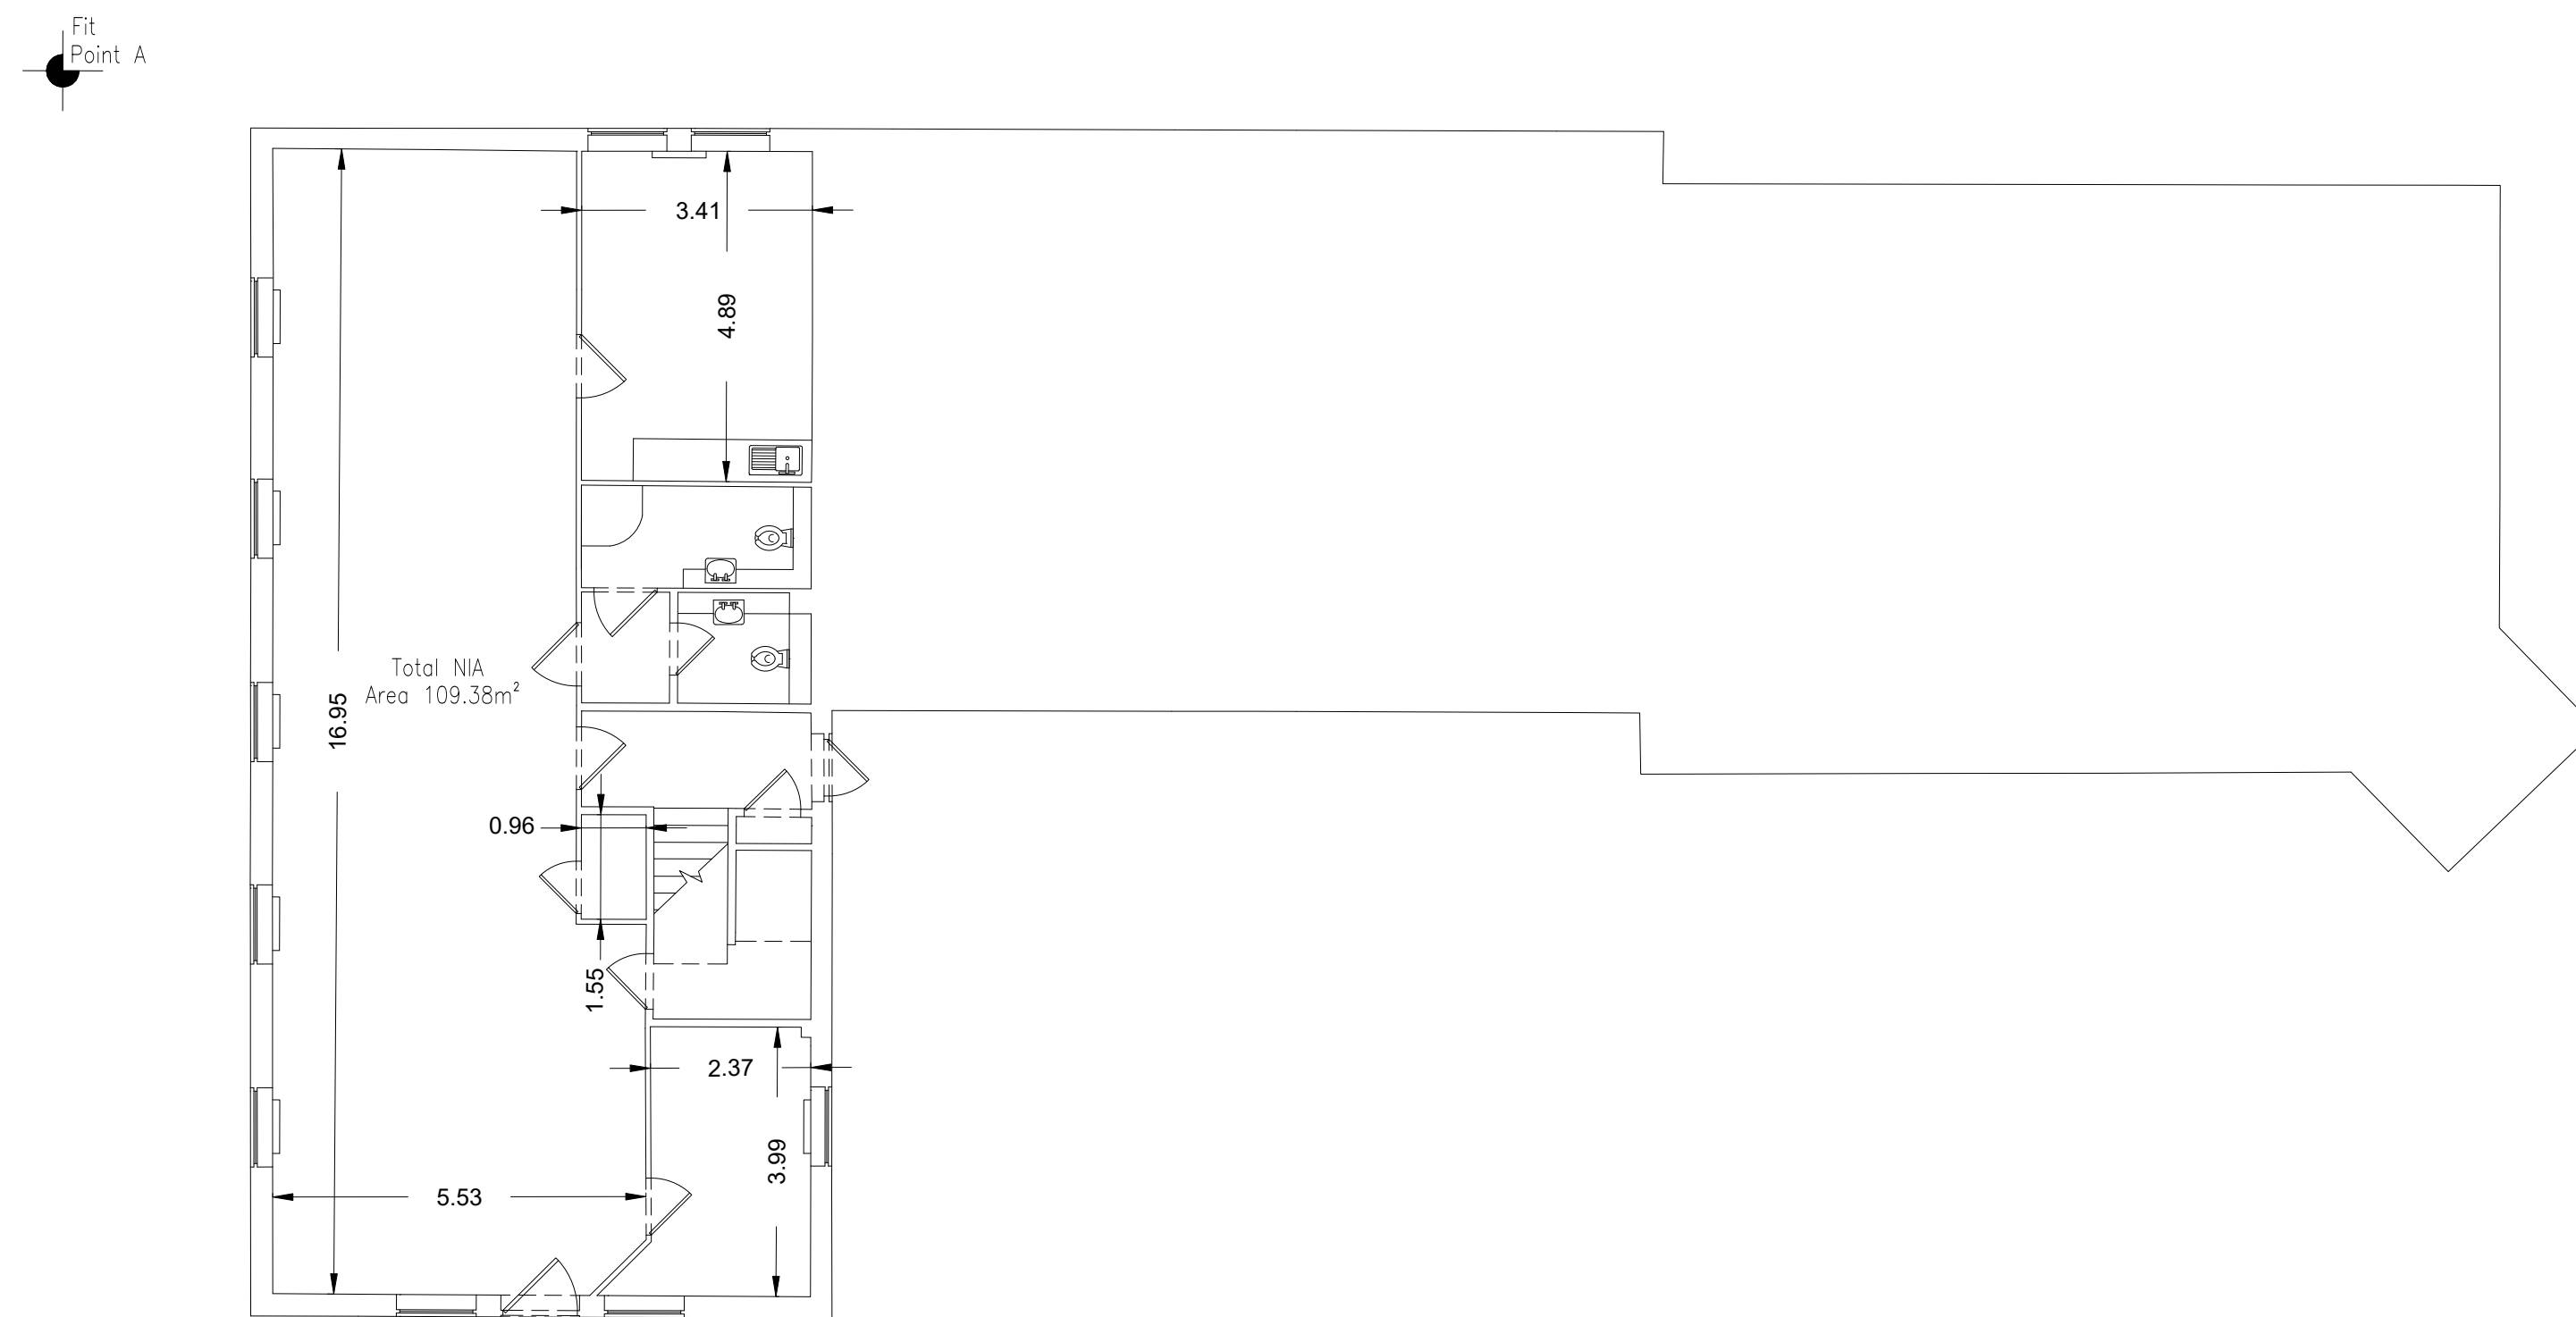

Legend:	
Abbreviated Features:	Symbols:
AB Air Brick	Light
B Bolster	Light
C/B Close Boarded	Emergency Light
C-H	Sign Light
CL Chain Link	Walled Mount Light
CL Ceiling Panel	Moist Point
CPD Cupboard	Roller Door
CR Crown Point Level	Sliding Door
DH Door Hight	Roller Door
FE Fire Exit	Sliding Door
F-C Floor to Gird	Superheated Ceiling Level
FL Floor Level	SP Sprink Sprink Level
FW Full Water	W-L Water Level
MH Manhole	US Surface Water
IC Dully	US Surface Water
IC Inspection Chamber	UTL Unable to Lift
IL Invert Level	V Vent
I/R Iron Roofings	
	Radiator
	Light
	Emergency Light
	Sign Light
	Walled Mount Light
	Moist Point
	Roller Door
	Sliding Door
	Roller Door
	Pendant Switch
	Block Pipe
	Light Switch
	Pendant Switch
	Block Pipe
	Alarm Bell
	Fire Alarm Push
	Shower Indicator
	Alarm Panel
	Thermostat
	Water
	Fuse Box
	Electric Box
	Hotter
	Water Stop Tap
	Overheat Features


Plan Coordinate Control:- N/A
Level Datum:- All Levels relate to OSGB36 using GPS

Key:

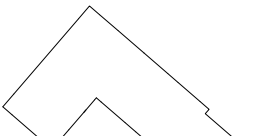

Notes:

REV A	Areas & Dimensions added.	07/03/25	SJH
REV NO	REV NOTE	DATE	SIGNED

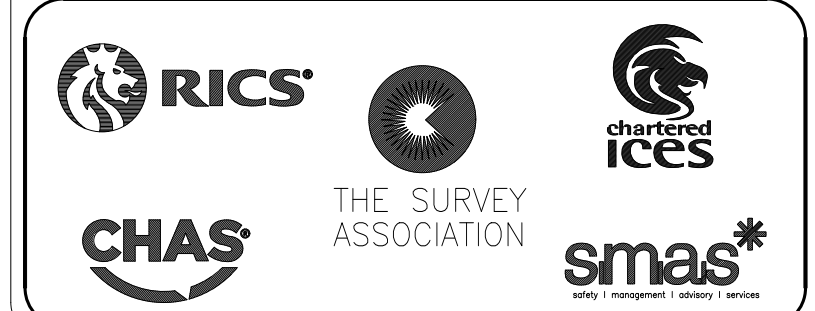

**GLOBAL
SURVEYS**

3 Brookfield, Duncan Close,
Moulton Park, Northampton, NN3 6WL.
Tel: 01604 491543
Email: info@globalsurveys.co.uk

Site:	Warren Park Wolverton Milton Keynes MK12 5NF
Client:	Milton Keynes Parks Trust
Survey Title:	Measured Building Survey 9 Warren Yard Floor Plans

Date	February 2025	Scale	1/100 @ A1
Dwg. No.	24708_9_WY	Surveyor	KMG
Sheet	1 of 1	Checked	SJH