



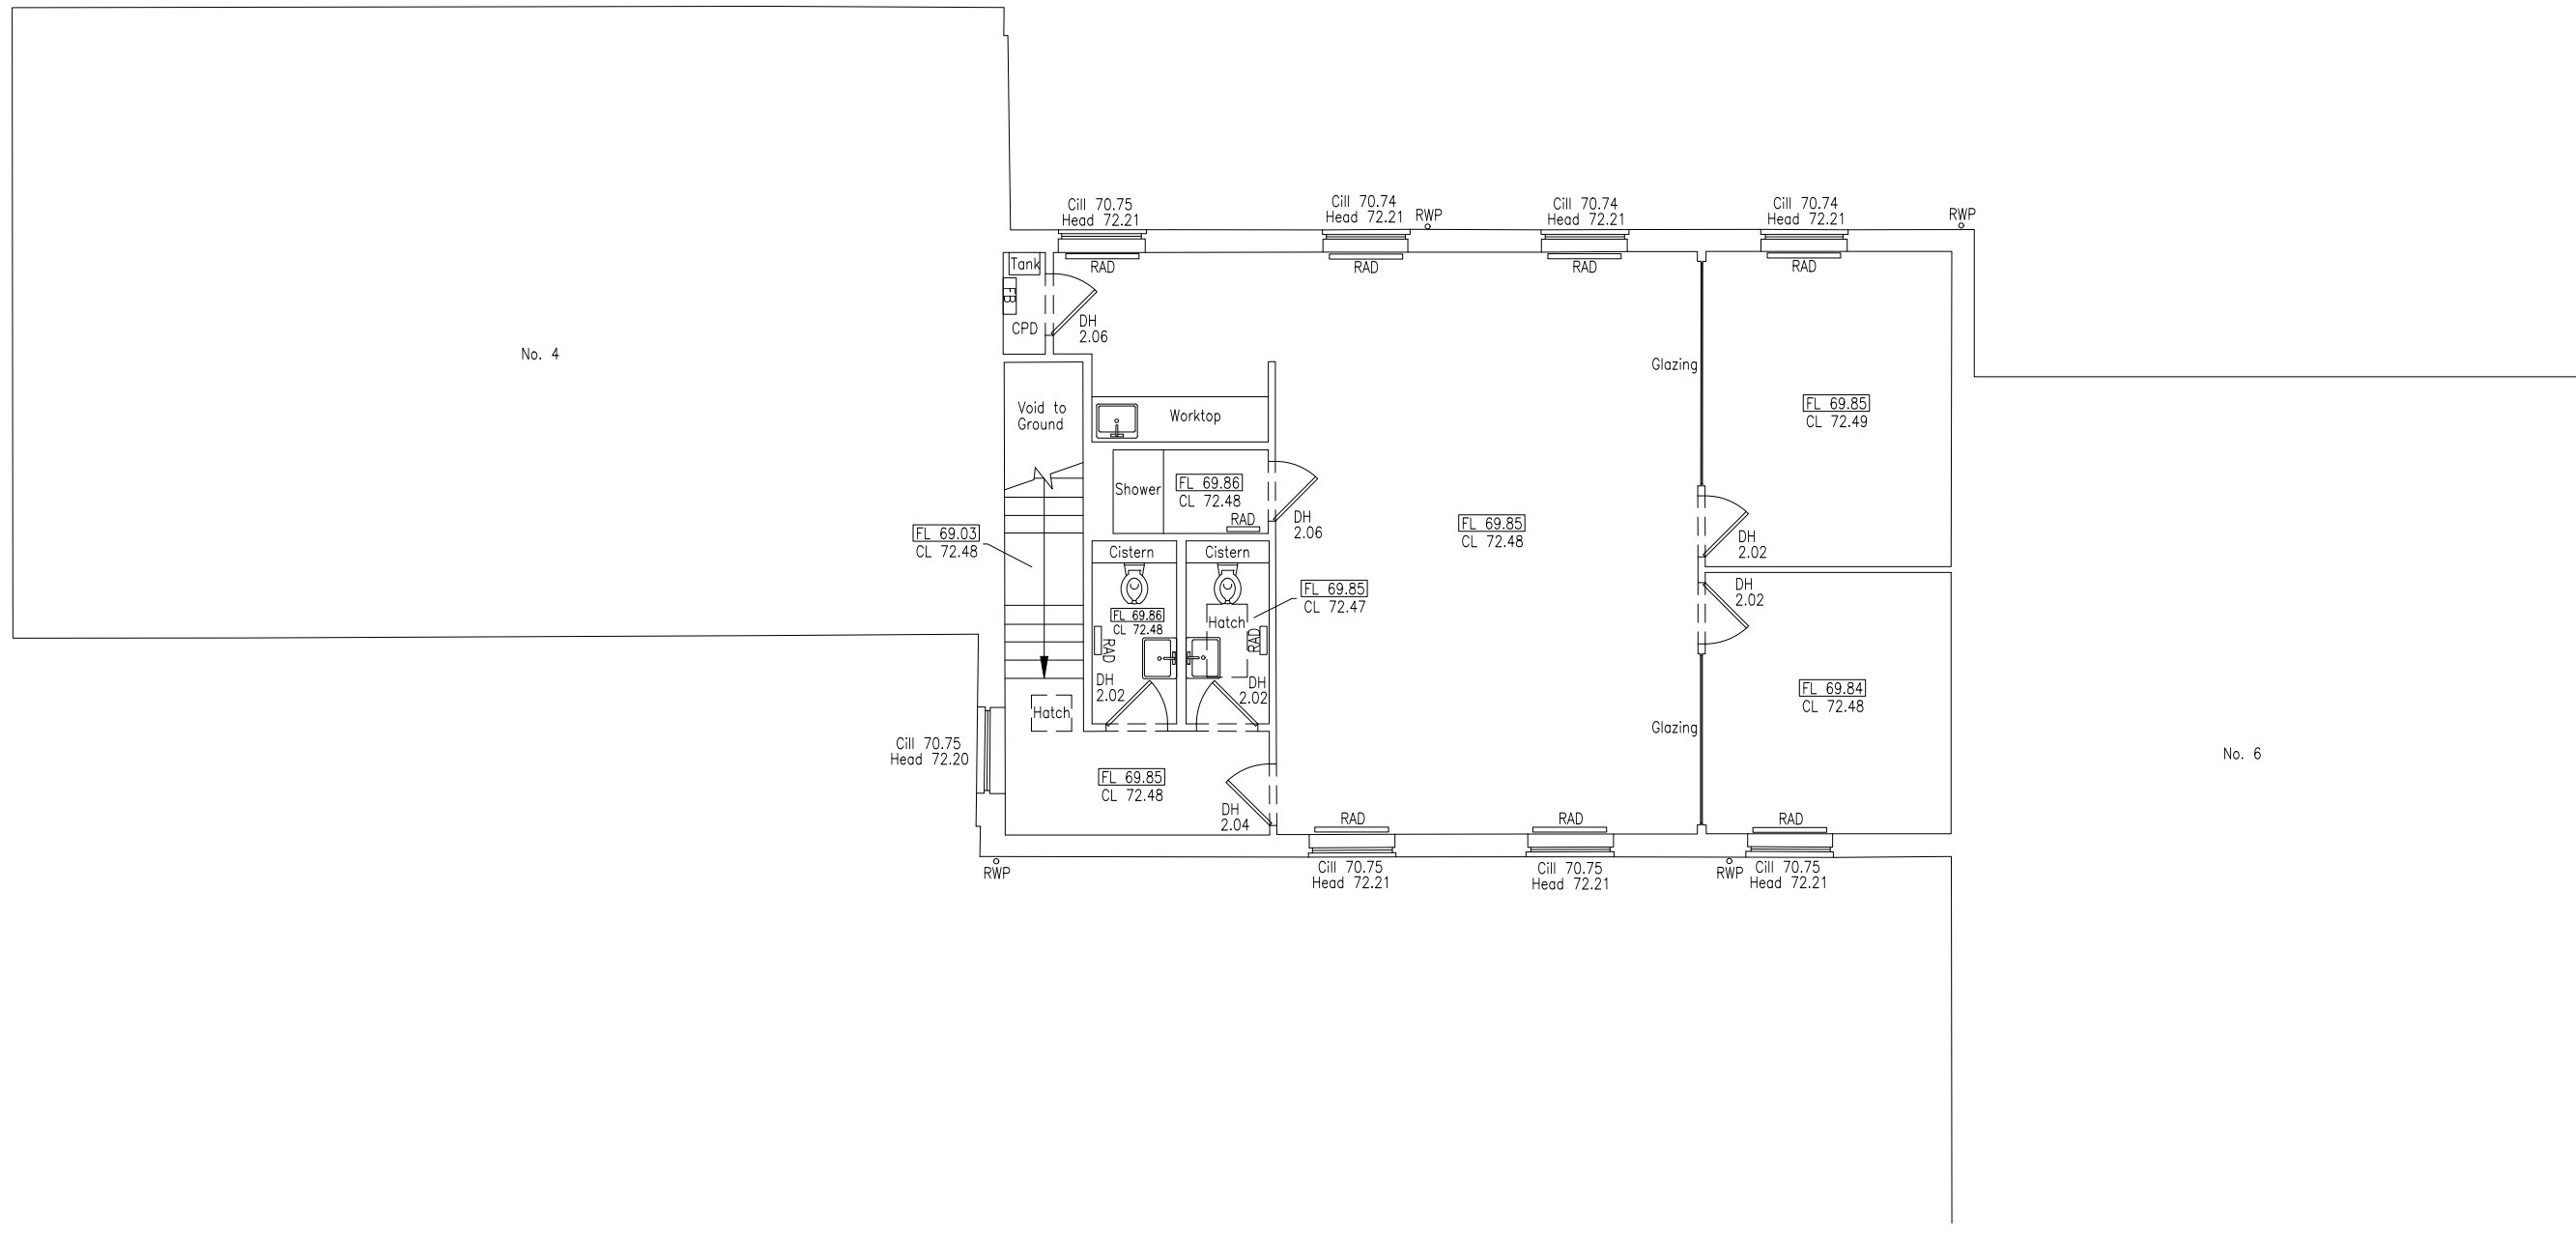

FIRST FLOOR PLAN

Fit
Point A


Fit
Point B

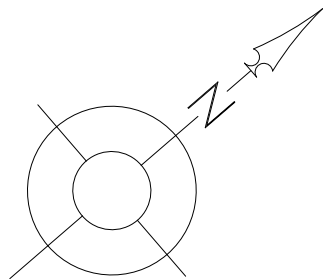

Legend:			
Abbreviated Features:	Symbols:		
AB Air Brick	LI Light	Radiator	RA
B Ballard	D/F Overflow Pipe	Light	⊗
C/B Close Boarded	P Post	Emergency Light	⊗
C-H C/H to Head	P/C Pitched Ceiling	Strip Light	—
C/L Chain Link	PE Pipe	Wall Mounted Light	—
CL Ceiling Level	P/R Pitched Roof	Mains Point	—
CPD Cupboard	P/W Point & Wire	Blank Plate	—
CR Crown Point Level	RD Roller Door	Light Switch	✓
DH Door Height	RNP Rainwater Pipe	Pendant Switch	⌵
Dr Drain	SD Sliding Doors	Isolator Switch	⌵
FE Fire Exit	SC Suspended Ceiling Level	Alarm Bell	⌵
F-C Floor to C/H	SP Spring Point Level	Alarm Panel	⌵
FL Floor Level	SW Surface Water	Alarm Panel	⌵
FW Four Water	US Understore	Thermotat	⌵
MH Manhole	UTL Unable To Lift	Thermotat	⌵
US Dully	VP Vent Pipe	Thermotat	⌵
IC Inspection Chamber	VI Vent	Thermotat	⌵
IL Invert Level		Thermotat	⌵
I/R Iron Rollings		Thermotat	⌵

Plan Coordinate Control:-
N/A

Level Datum:-
All Levels relate to OSGB36 using GPS

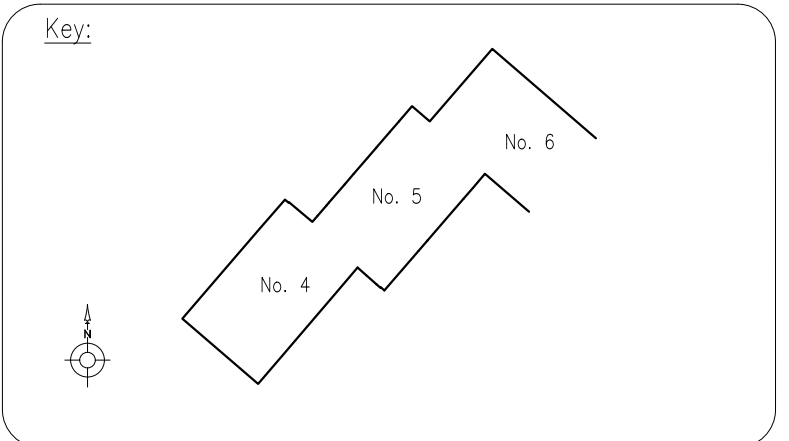

Notes:

REV	NO	REV	NOTE	DATE	SIGNED





3 Brookfield, Duncan Close,
Moulton Park, Northampton, NN3 6WL
Tel: 01604 491543
Email: info@globalsurveys.co.uk

Site:	No. 5 Canon Harnett Court Milton Keynes MK12 5NF
Client:	The Parks Trust
Survey Title:	Measured Building Survey First Floor Plan

Date	June 2025	Scale	1/100 @ A1
Dwg No.	24995-MBS	Surveyor	SPH
Sheet	1 of 1	Checked	SJH