

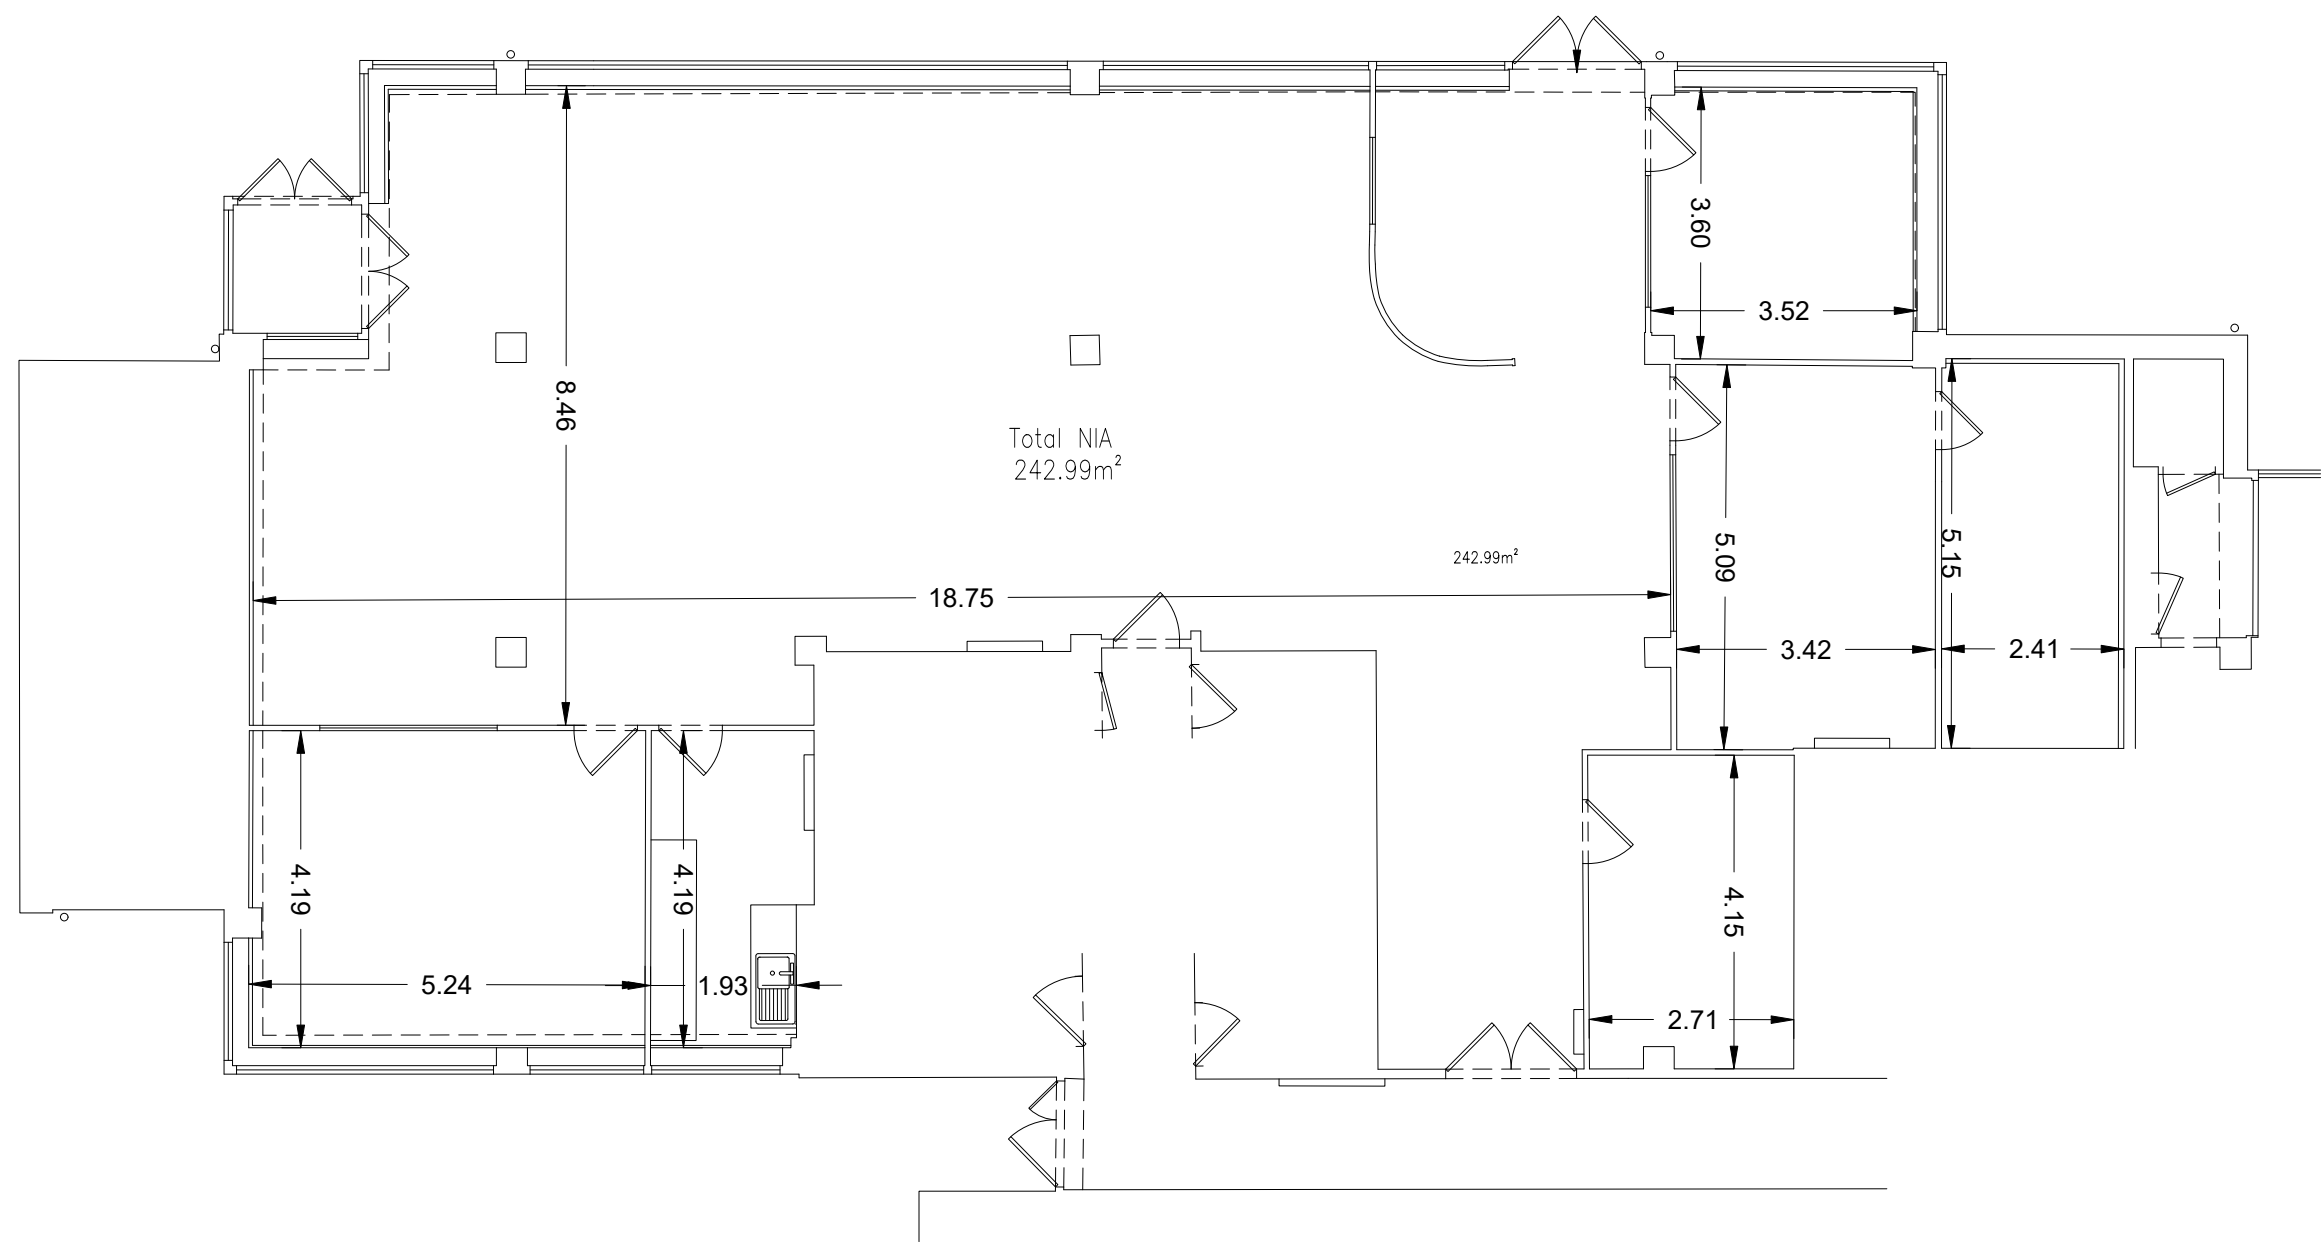


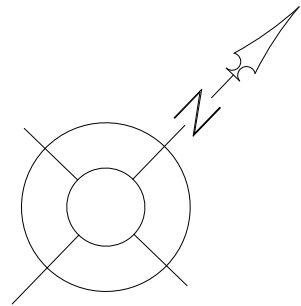


GROUND FLOOR PLAN

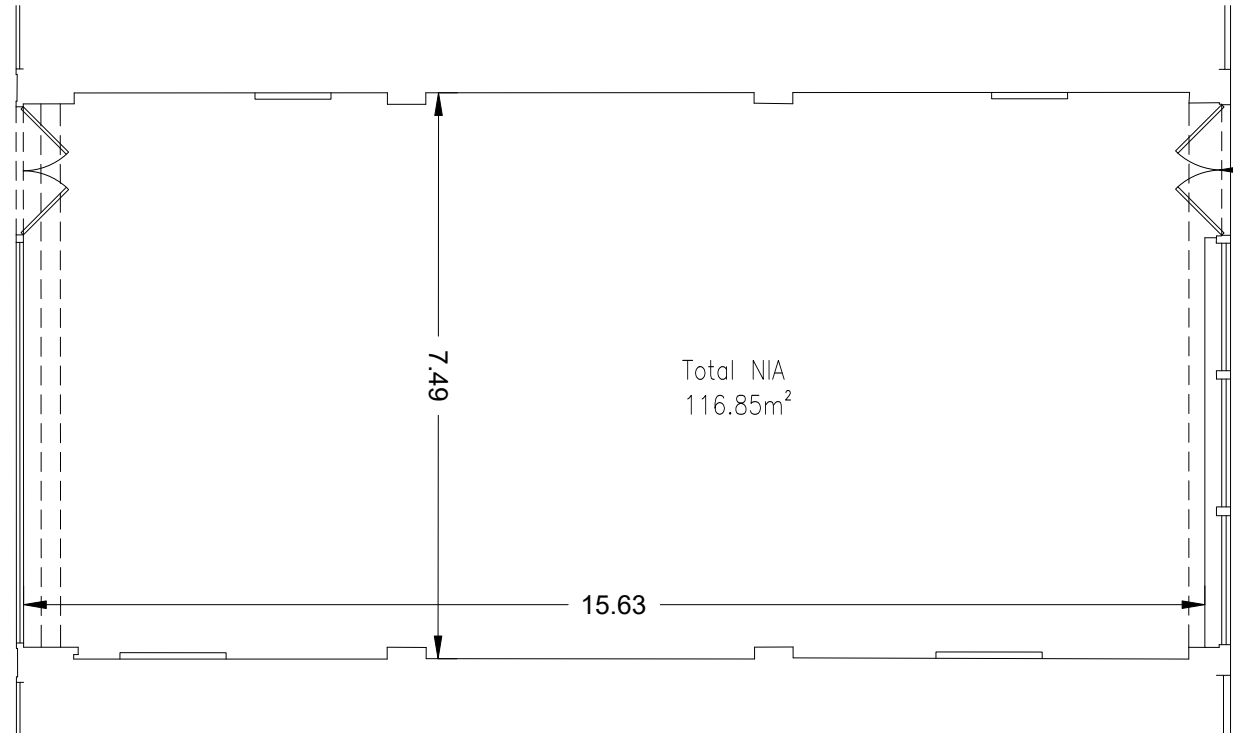


Legend:			
Abbreviated Features:	Symbols:		
AB Air Brick	LI Light	Radiator	AB
B Ballard	D/F Overflow Pipe	Light	⊗
C/B Close Boarded	P Post	Emergency Light	⊗
C-H Cill to Head	P/C Pitched Ceiling	Strip Light	—
C/L Chain Link	PS Pipe	Wall Mounted Light	—
CL Ceiling Level	P/R Pitched Roof	Mains Point	—
CPD Cupboard	P/W Pile & Wire	Blank Plate	—
CR Crown Point Level	RD Roller Door	Light Switch	—
DH Door Height	RD Rodding Eye	Pendant Switch	—
Dr Drain	RNP Runover Pipe	Isolator Switch	—
FE Fire Exit	SD Sliding Doors	Alarm Bell	—
F-C Floor to Cill	SL Suspended Ceiling Level	Alarm Bell	—
FL Floor Level	SP Spring Point Level	Fire Alarm Push	—
FW Four Water	SW Soil & Vent Pipe	Snow Detector	—
MH Manhole	SW Surface Water	Alarm Panel	—
LS Underdrain	UTL Unclimb To Lift	Alarm Panel	—
IC Inspection Chamber	VP Vent Pipe	Thermotat	—
IL Invert Level	VI Vent	Modern	—
I/R Iron Railings		Fuse Box	—
		Electric Box	—
		Heater	—
		Water Stop Tap	—
		Overhead Features	— — — —

Plan Coordinate Control:—
N/A
Level Datum:—
All Levels relate to OSGB36 using GPS

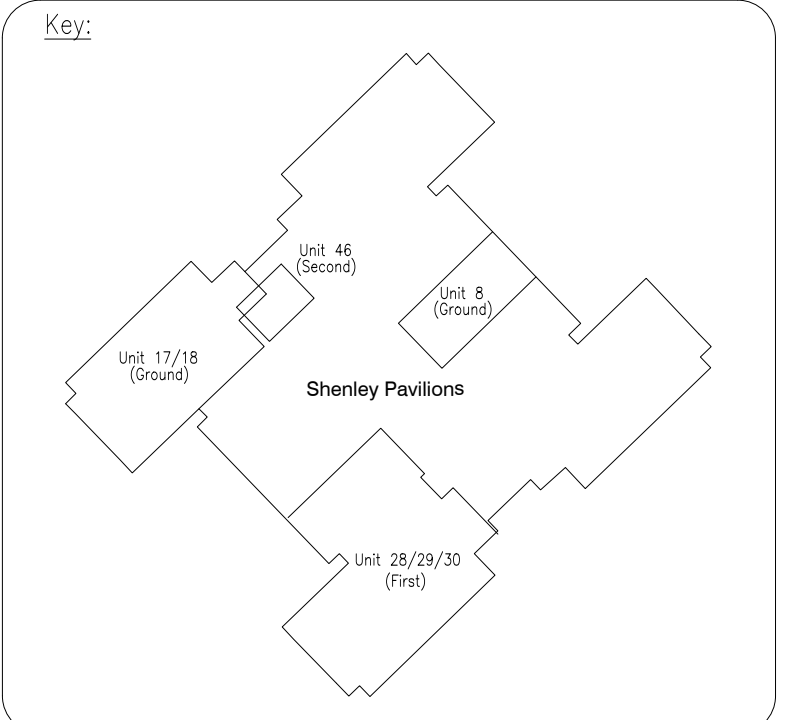

Notes:

A	Areas & room dimensions added	07/03/2025	GD
REV NO	REV NOTE	DATE	SIGNED

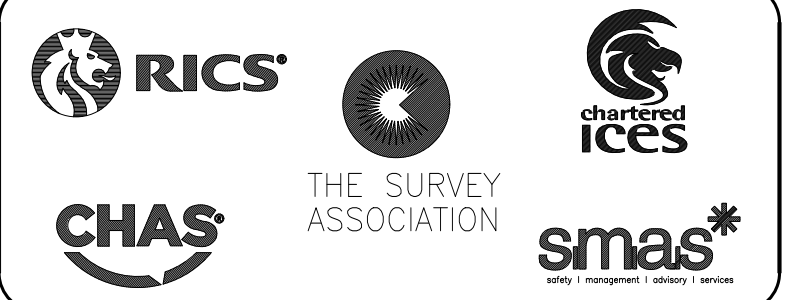



GLOBAL SURVEYS

3 Brookfield, Duncan Close,
Moulton Park, Northampton, NN3 6WL
Tel: 01604 491543
Email: info@globalsurveys.co.uk

Site:	Shenley Pavilions Chalkdell Drive, Shenley Wood Milton Keynes, MK5 6LB
Client:	Milton Keynes Parks Trust
Survey Title:	Measured Building Survey Ground Floor Plans

Date	February 2025	Scale	1/100 @ A1
Dwg No.	24707-MBS	Surveyor	GD
Sheet	1 of 2	Checked	SJH