



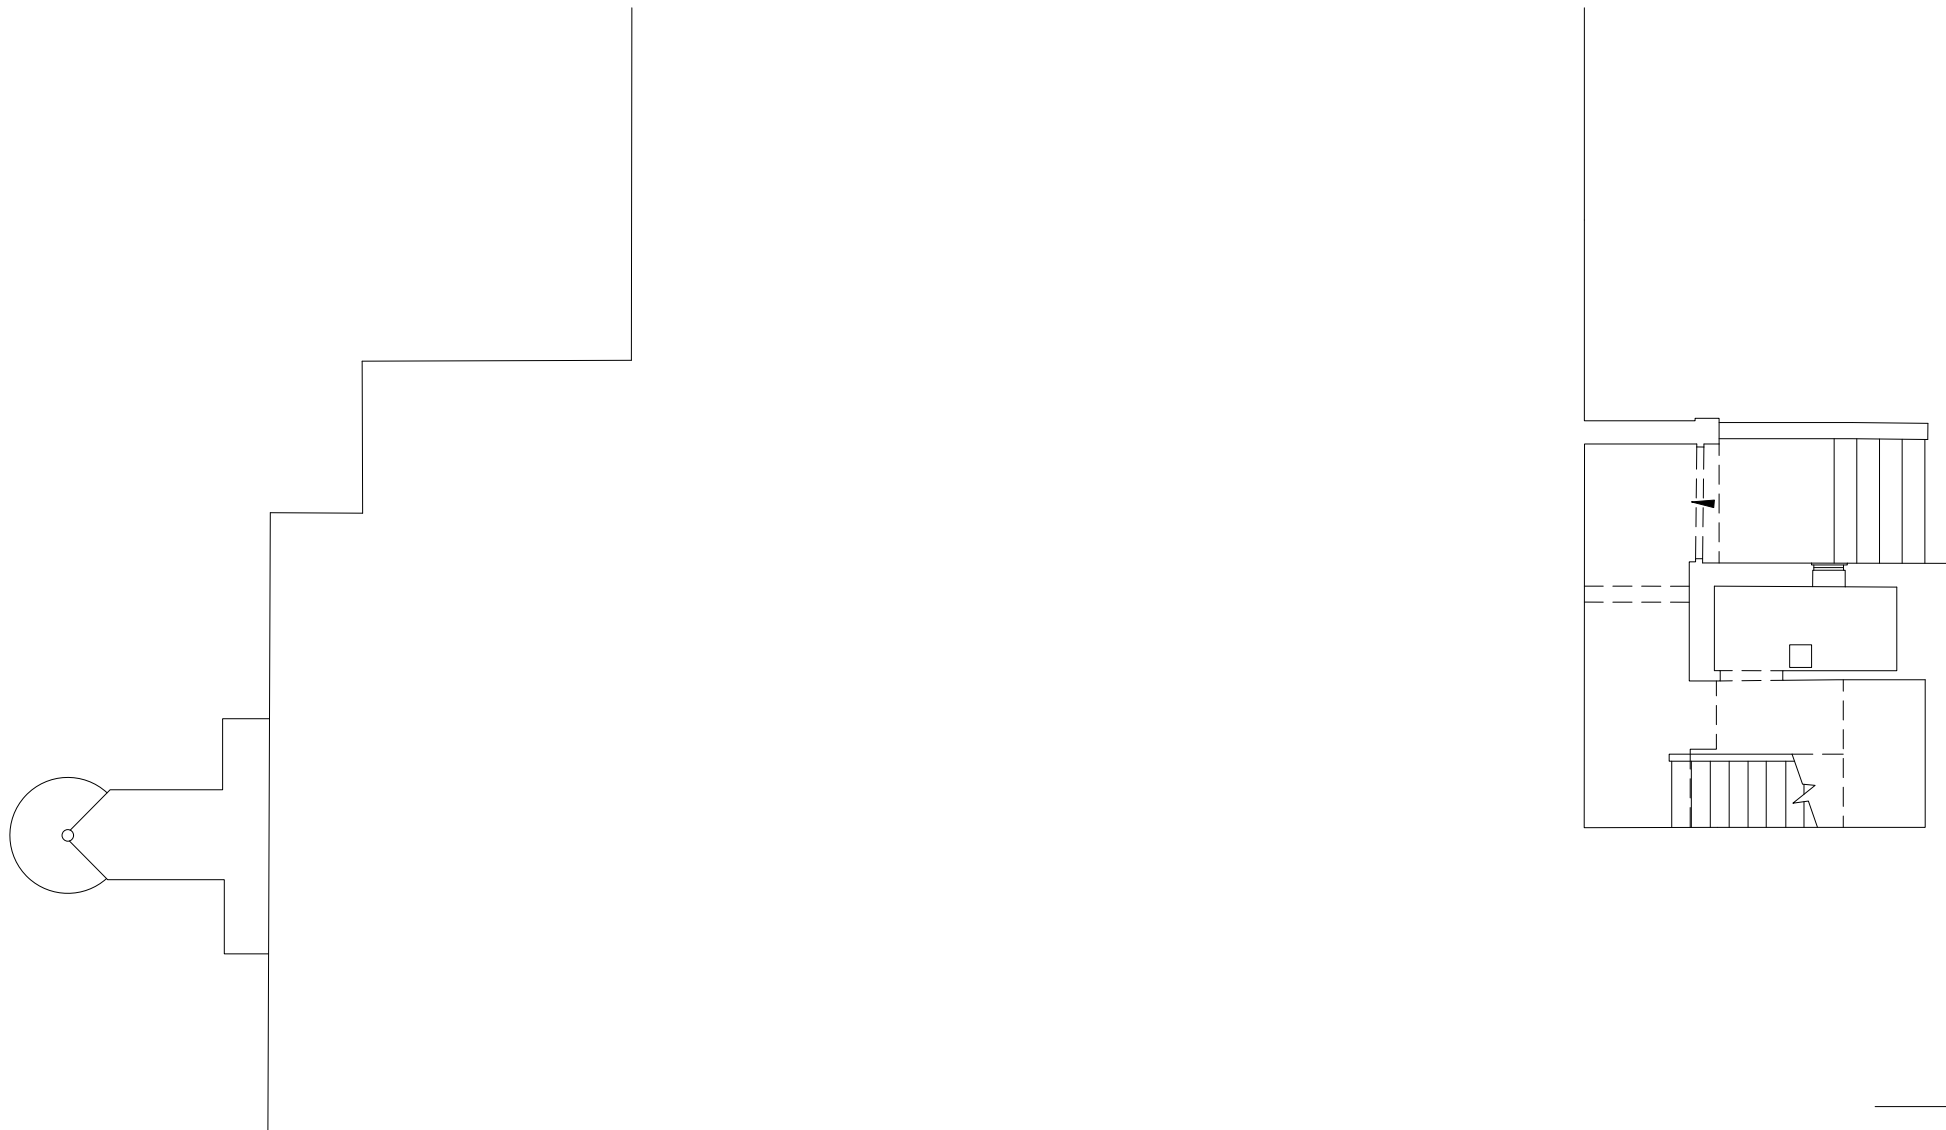

GROUND FLOOR PLAN

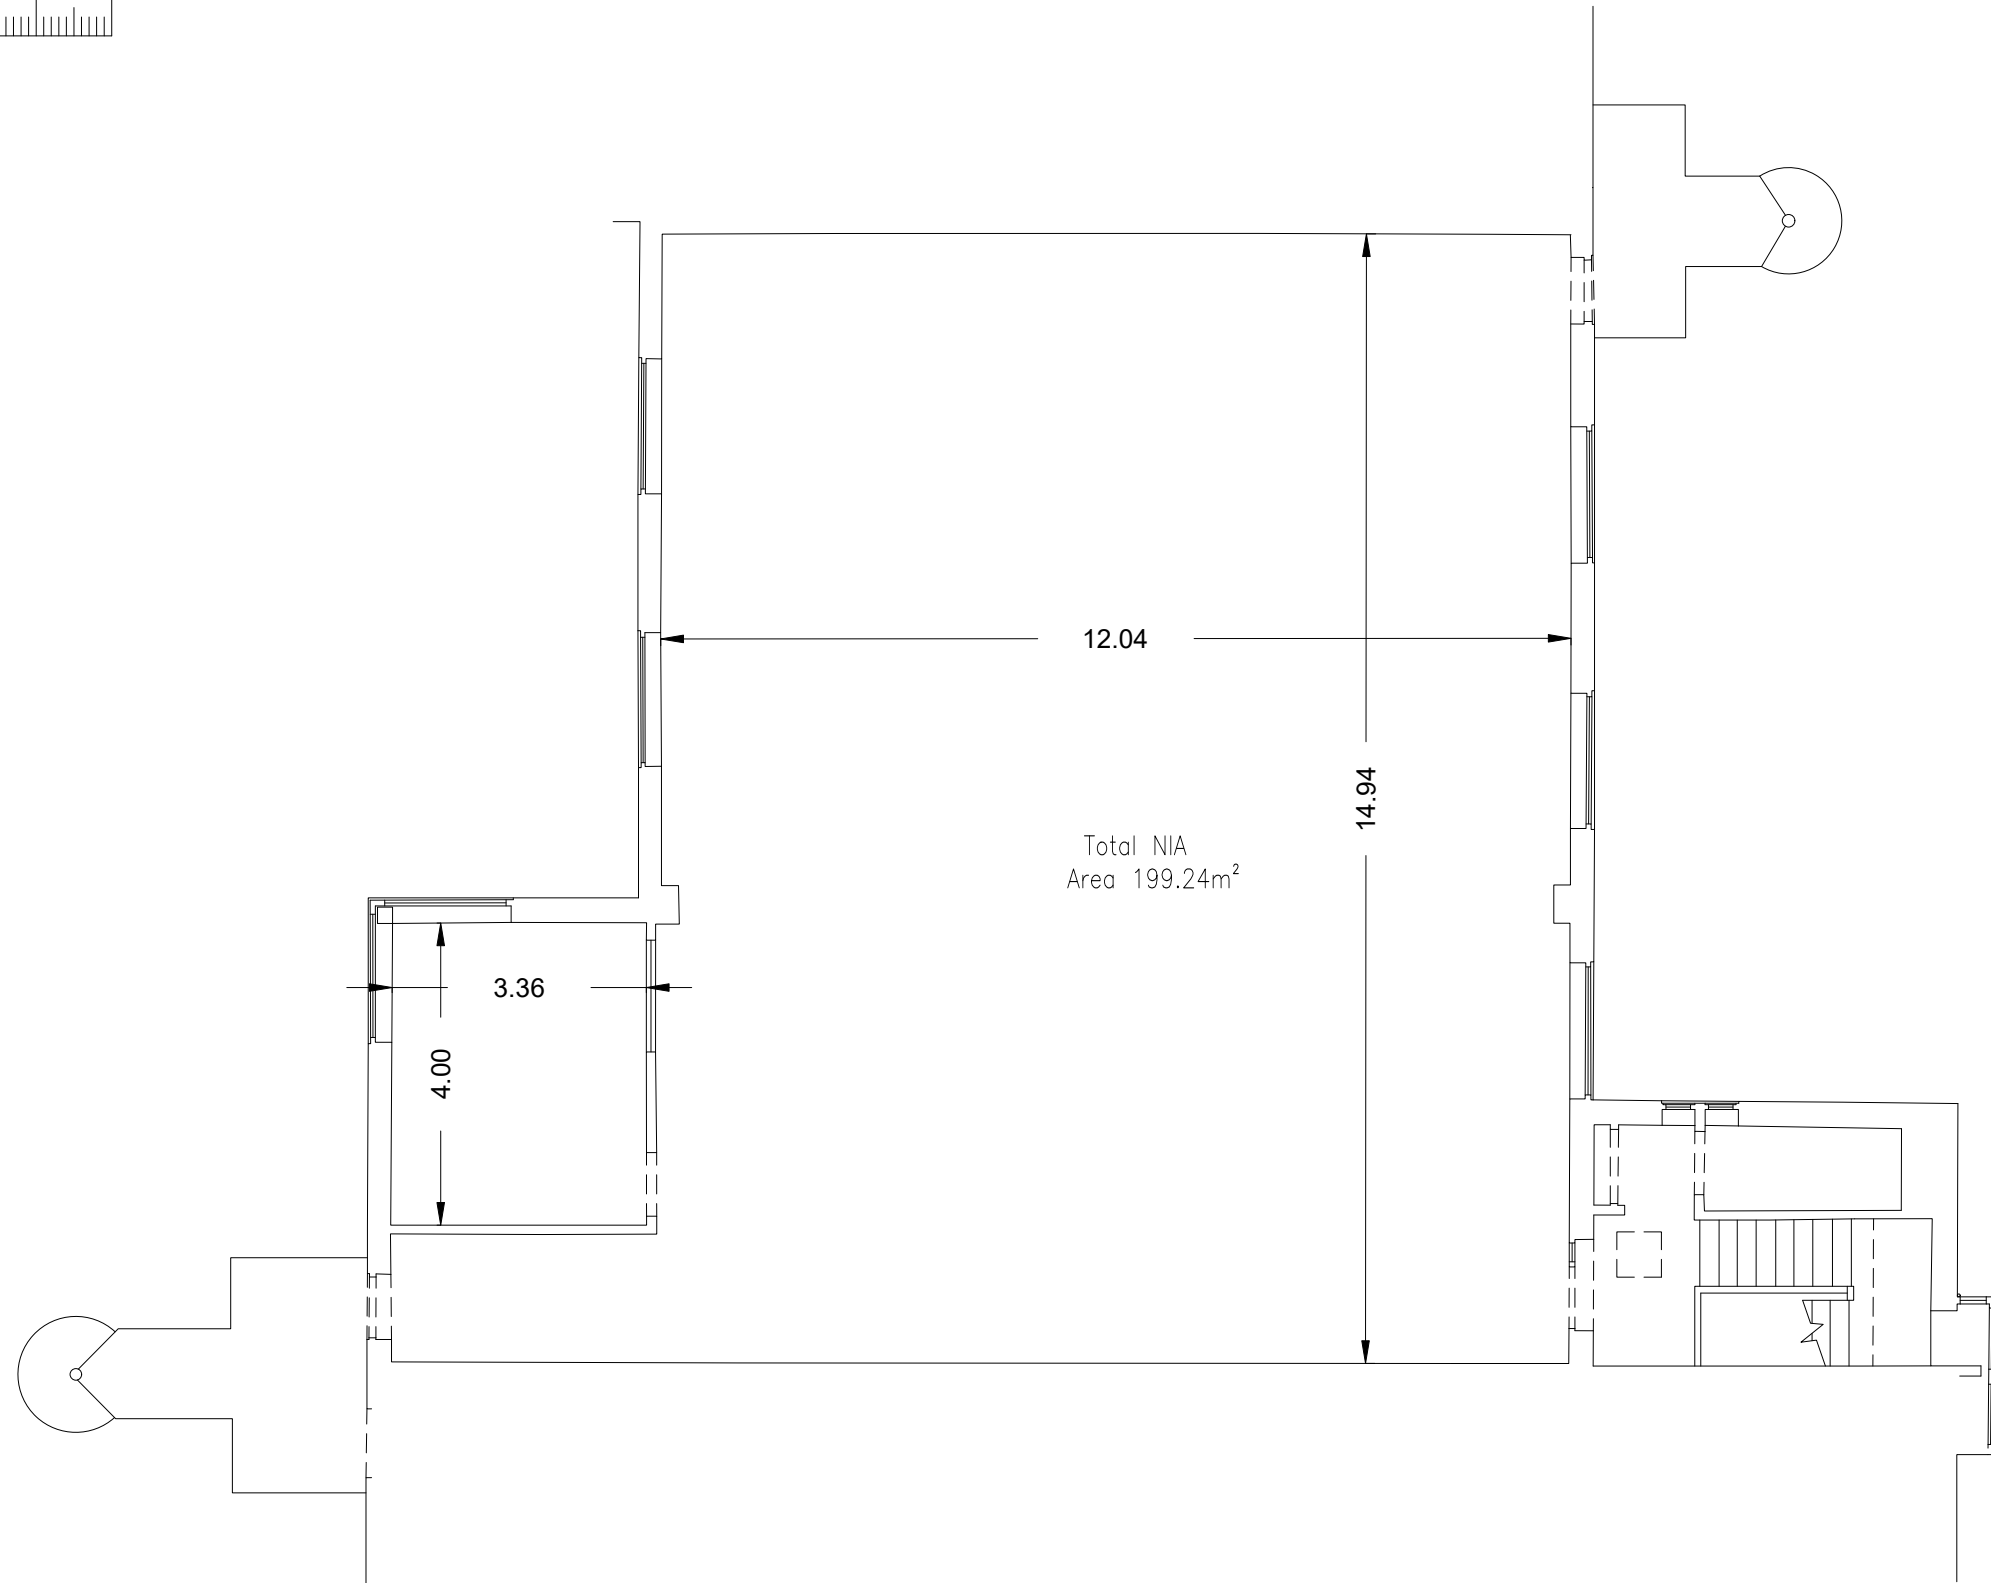


FIRST FLOOR PLAN

Legend:		
Abbreviated Features:	Symbols:	
AB Air Brick	LI Light	Radiator
B Ballard	O/F Overflow Pipe	Light
C/B Close Boarded	P Post	Emergency Light
C-H Cill to Head	P/C Pitched Ceiling	Strip Light
C/L Chain Link	PS Pipe	Wall Mounted Light
CL Ceiling Level	P/W Pitched Roof	Mains Point
CPD Cupboard	P/R Post & Wire	Blank Plate
CR Crown Point Level	RD Roller Door	Light Switch
DH Door Height	RE Radding Eye	Pendant Switch
Dr Drain	RNP Ranswater Pipe	Isolator Switch
FE Fire Exit	SD Sliding Doors	Alarm Bell
F-C Floor to Cill	SSL Suspended Ceiling Level	Fire Alarm Push
FL Floor Level	SP Spring Point Level	Snow Detector
FW Four Water	SV Soil & Vent Pipe	Alarm Panel
MH Manhole	SW Surface Water	Thermostat
U Under	US Underside	Modern
IC Inspection Chamber	UTL Unable To Lift	Fuse Box
IL Invert Level	VP Vent Pipe	Electric Box
I/R Iron Railings	VI Vent	Heater
		Water Stop Tap
		Overhead Features -----

Plan Coordinate Control:-
N/A

Level Datum:-
All Levels relate to OSGB36 using GPS

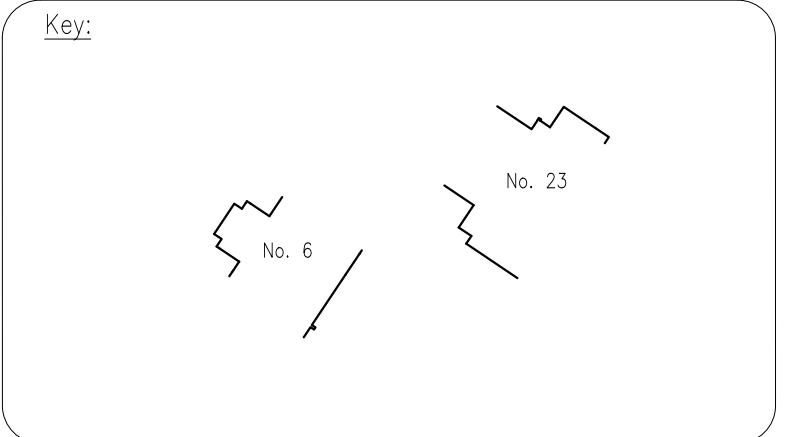

Notes:

B	Areas & room dimensions added.	07/03/25	S.JH
A	Units on separate sheets	03/03/25	KMG
REV	NO	REV	NOTE
		DATE	SIGNED

3 Brookfield, Duncan Close,
Moulton Park, Northampton, NN3 6WL
Tel: 01604 491543
Email: info@globalsurveys.co.uk

Site: Drakes Mews
Crownhill
Milton Keynes, MK8 0ER

Client: Milton Keynes Parks Trust

Survey Title: Measured Building Survey
Unit 23 Ground & First Floor Plans

Date	February 2025	Scale	1/100 @ A1
Dwg No.	24709-MBS-A	Surveyor	SPH
Sheet	2 of 2	Checked	S.JH